


Jigyasa Infratech PVT. LTD.

METRO HOMES - II

**PLOT SIZE - 12X25
= 300 SQFT.**

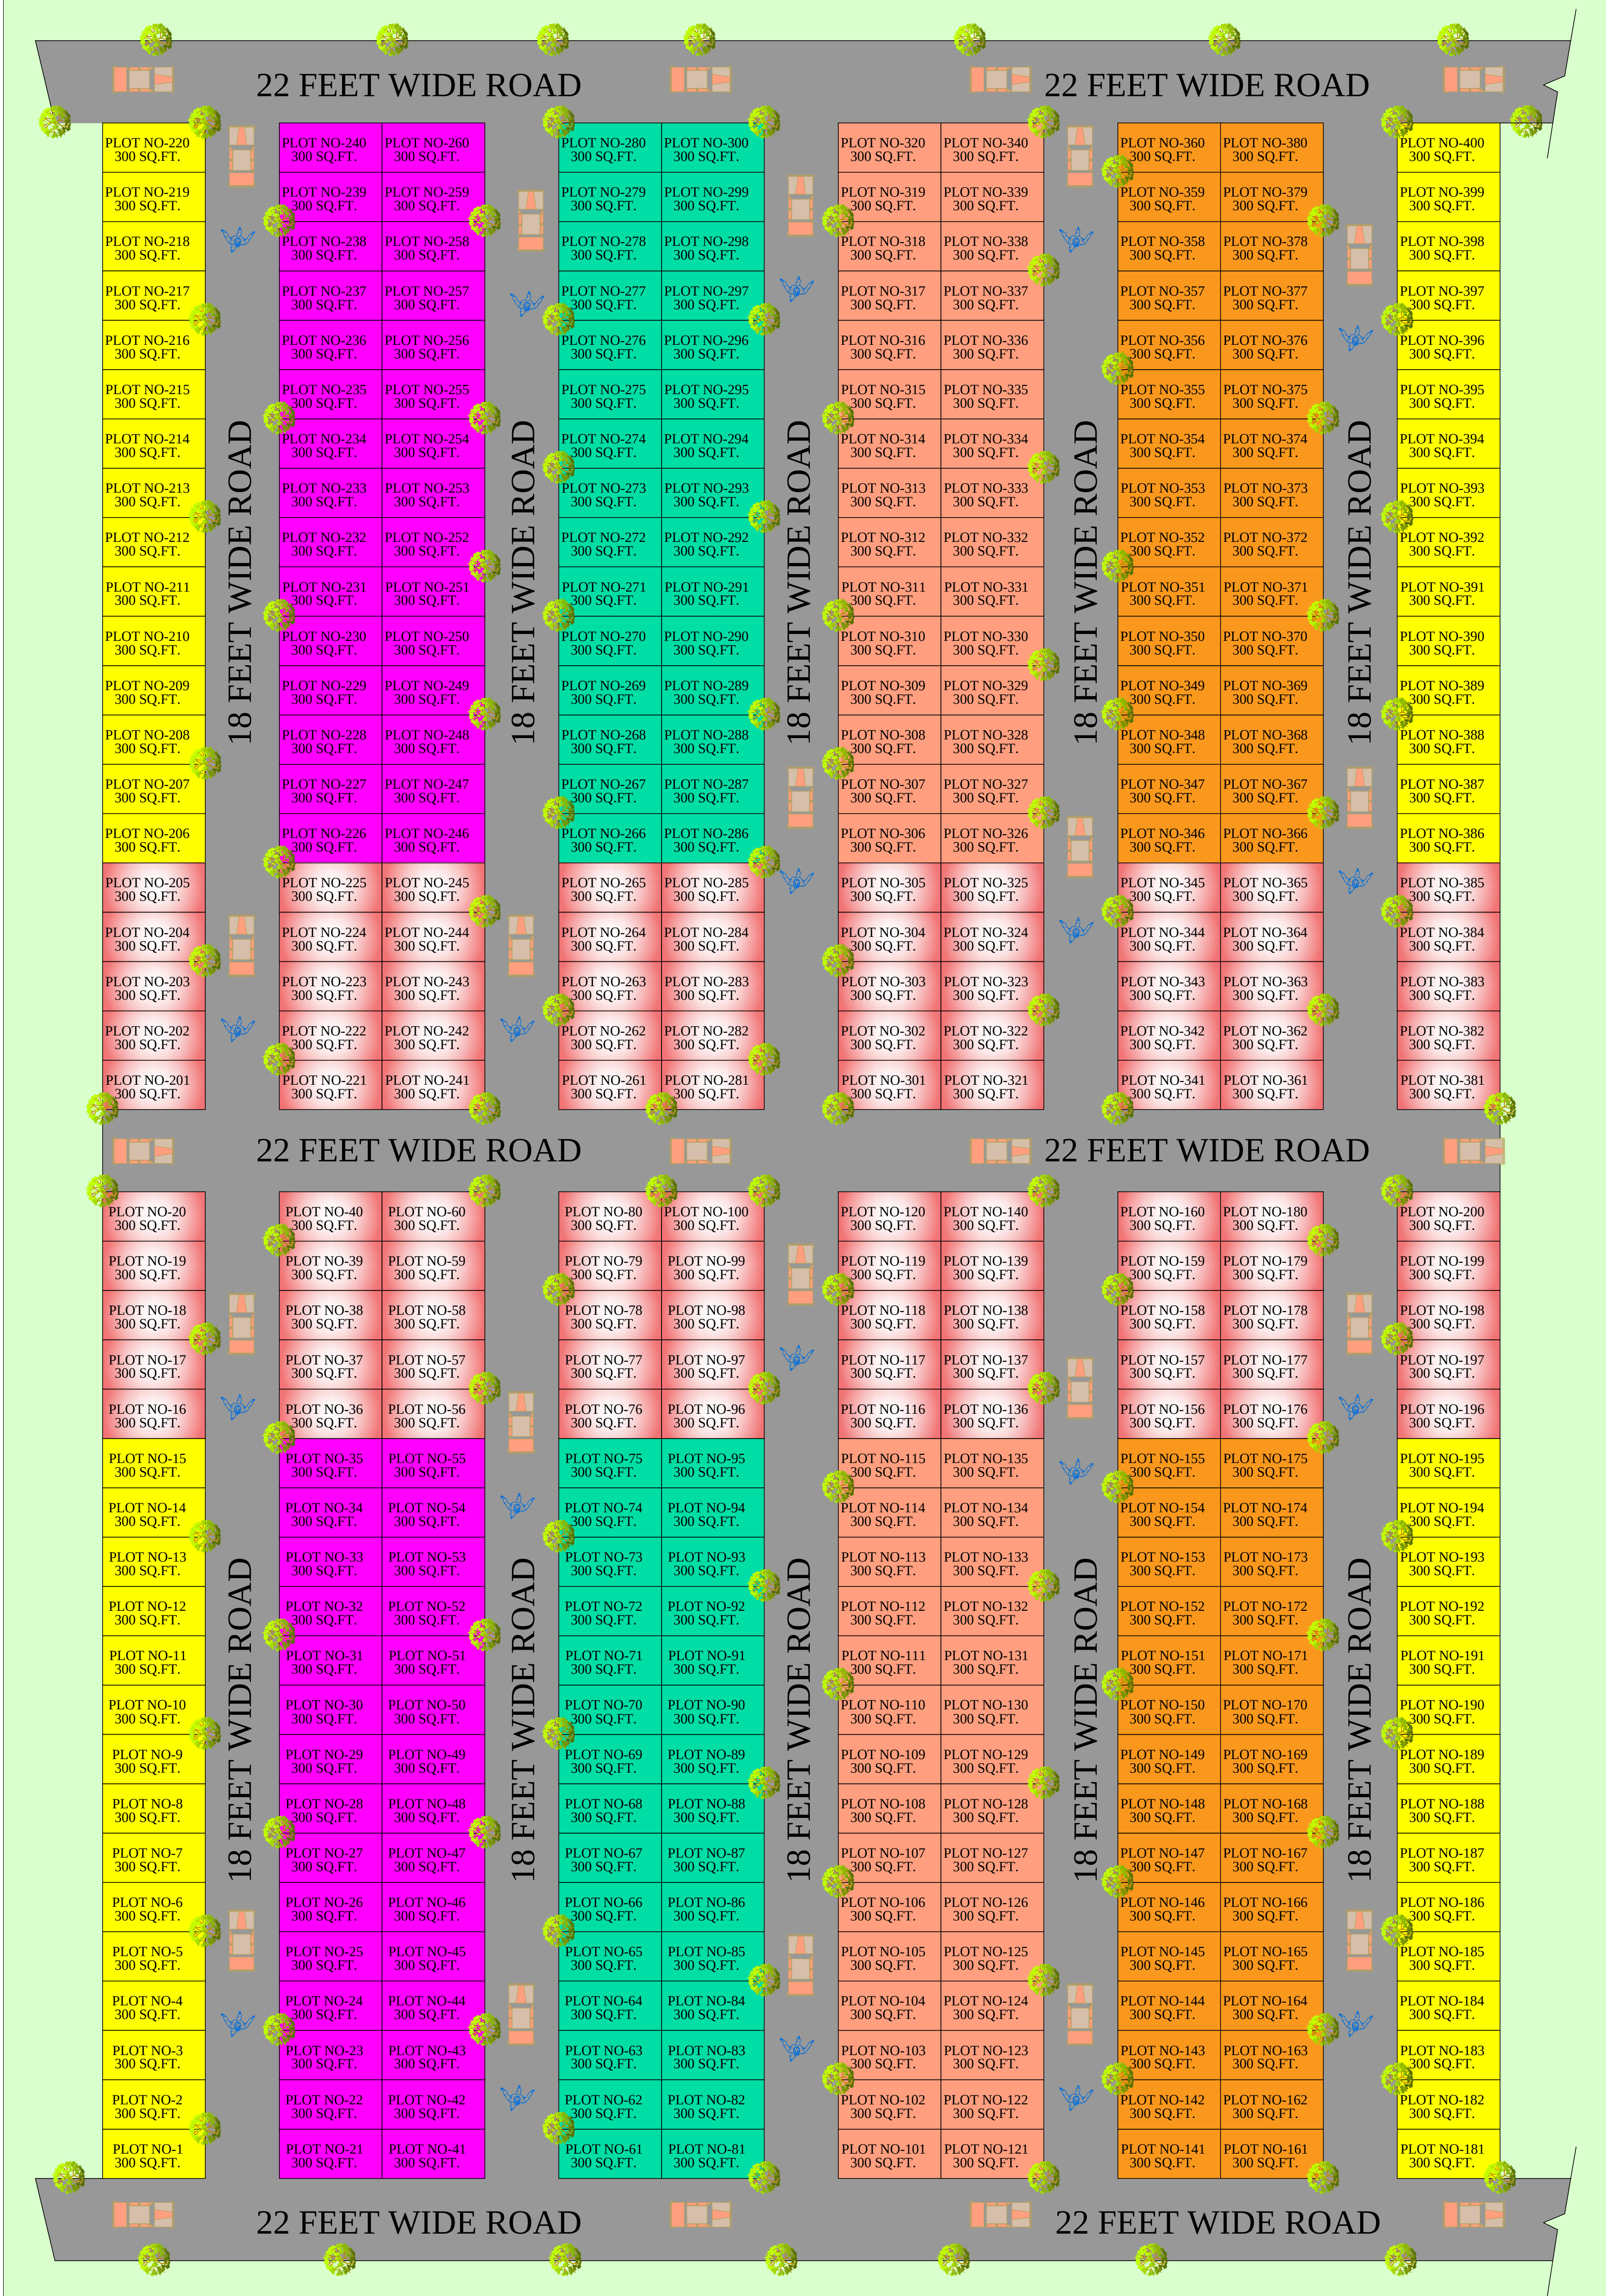

PROJECT DEVELOPED BY- JIGYASA INFRATECH PVT.LTD. AT BIRURA, LUCKNOW OFF: 239, SEC-9B, VRINDAVAN YOJNA, LUCKNOW		SITE PLAN	<u>Engineer Sign</u> Er.ABHISHEK SRIVASTAVA	LAYOUT DESIGNED BY- architecture engineering interiors turnkey projects OFF: 239, SEC-9B, VRINDAVAN YOJNA, LUCKNOW PHONE: 9120170843, 735564430
		scale : 1: 100		
		date: 22-12-2018		